


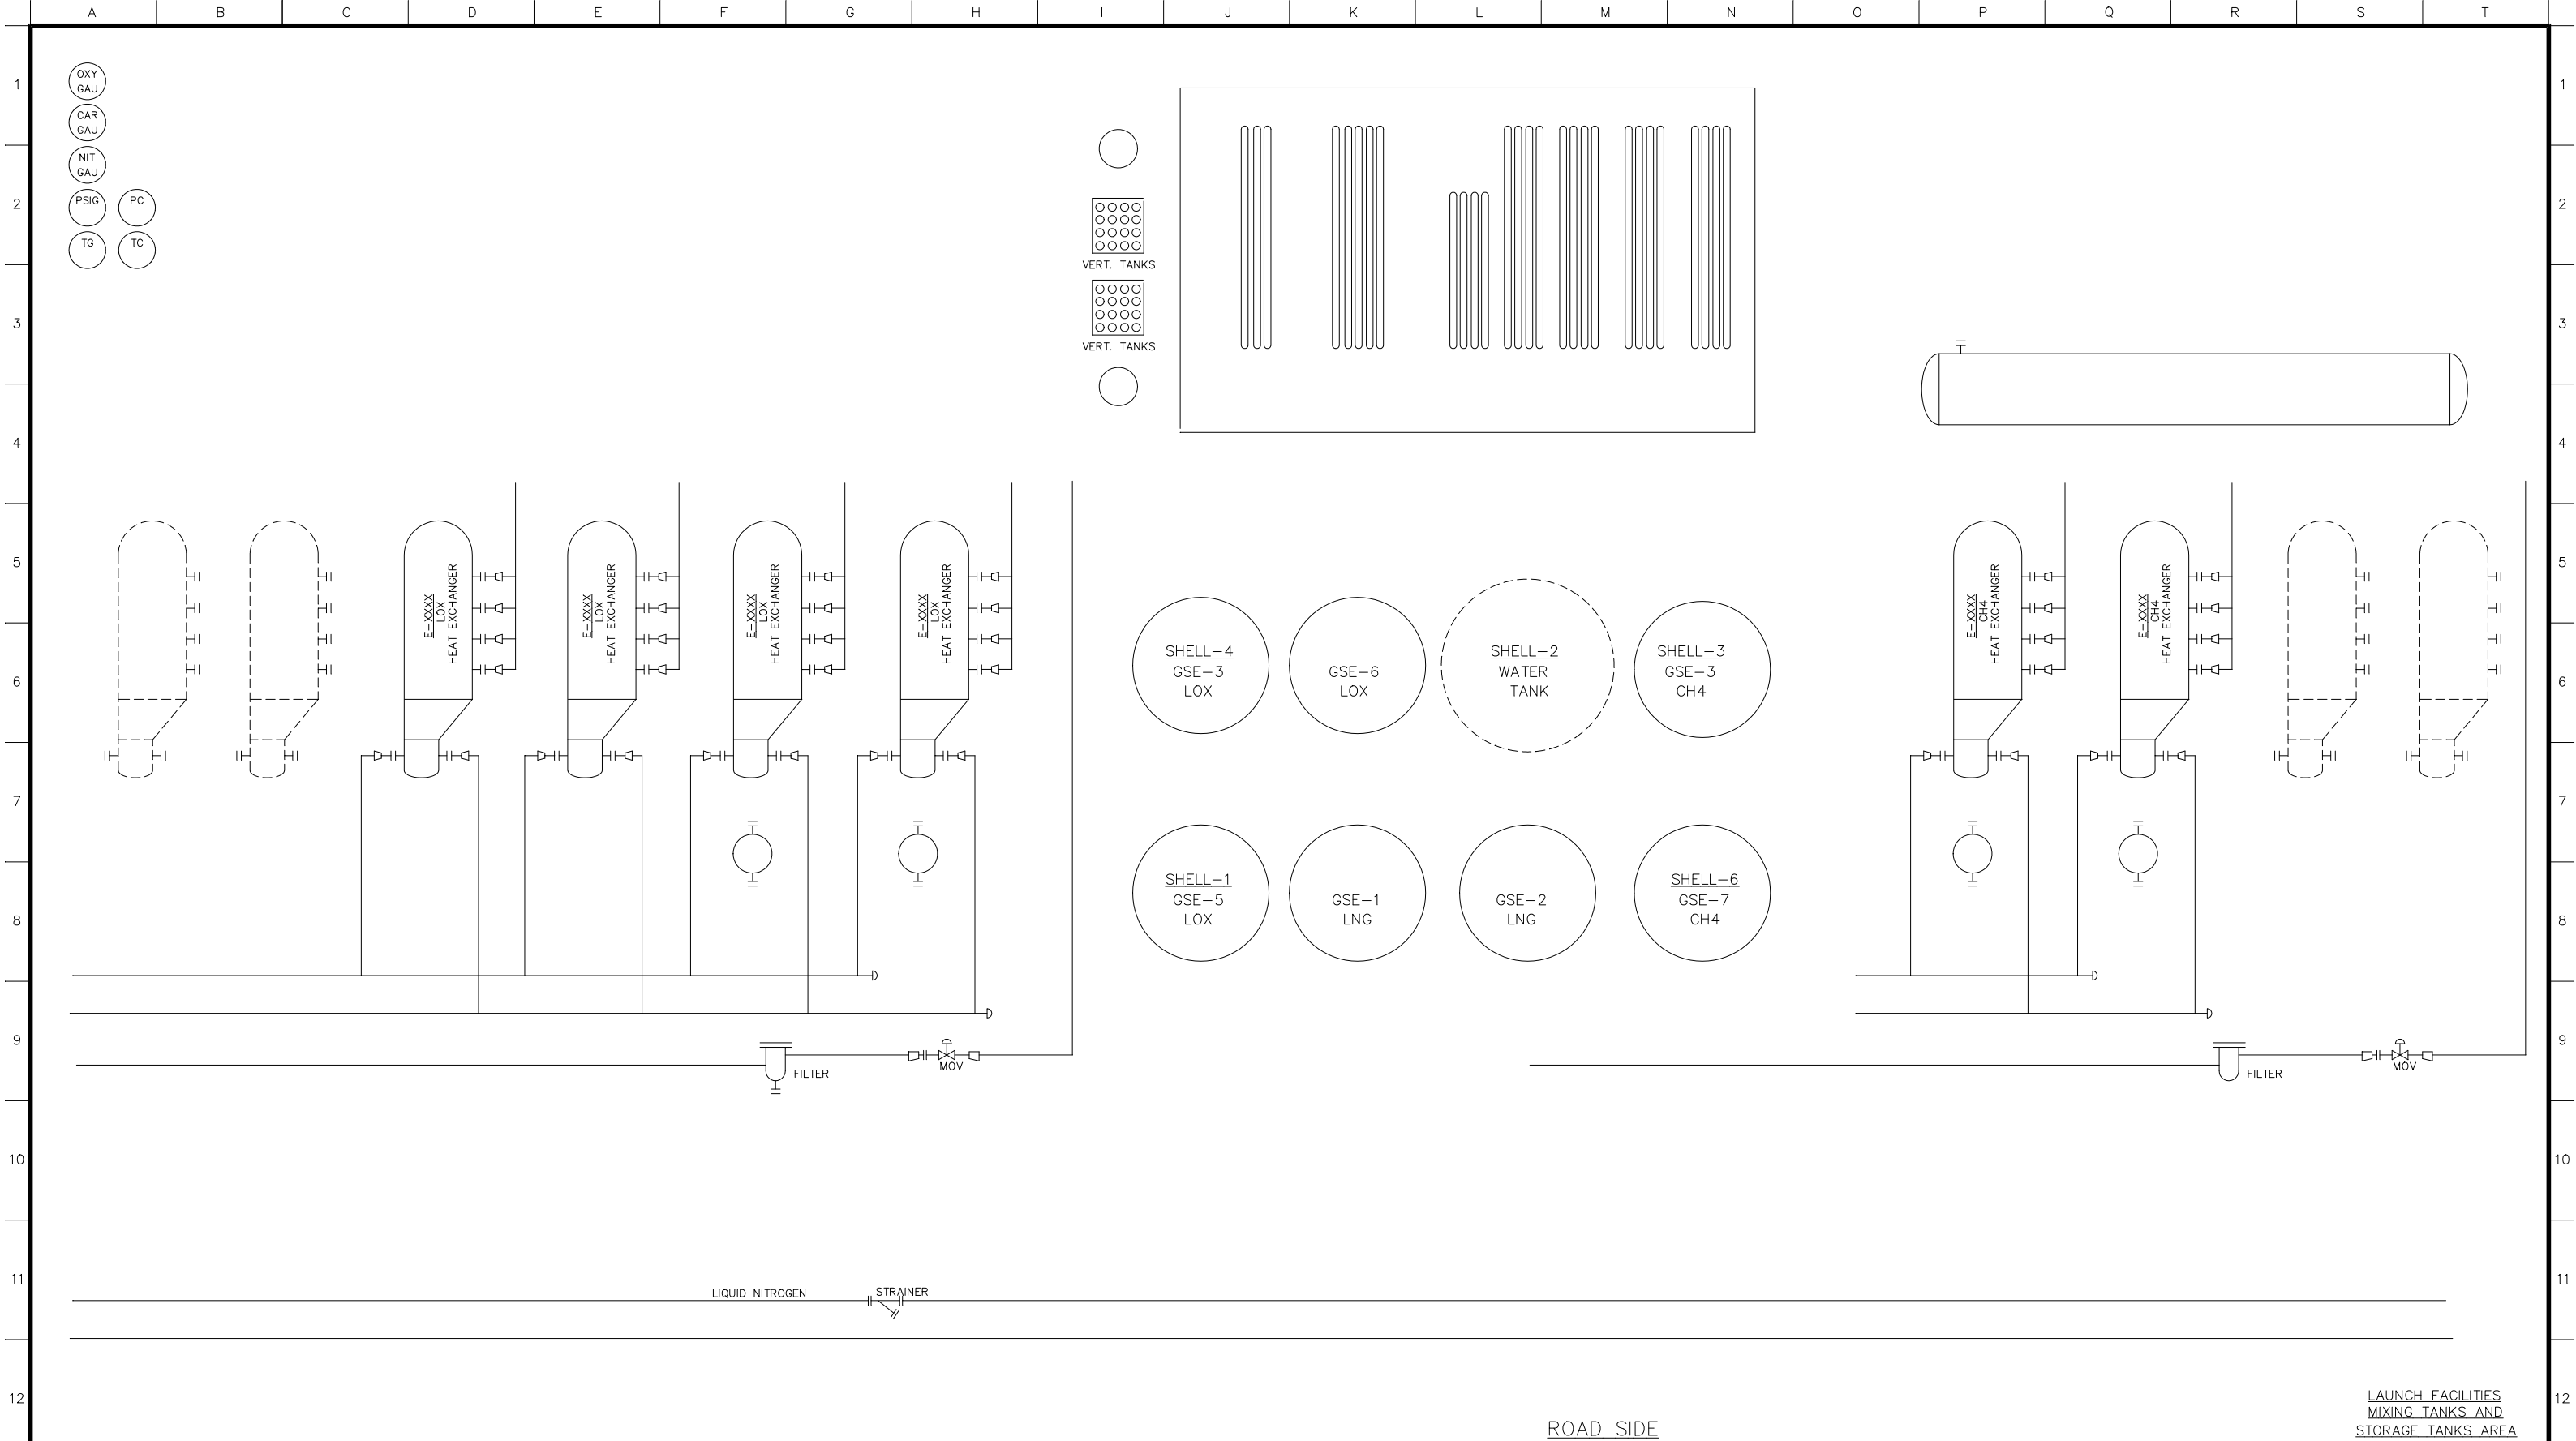

|       |     |                                                                                                                |     |           |          |                   |     |      |             |                    |                |                                                                             |       |
|-------|-----|----------------------------------------------------------------------------------------------------------------|-----|-----------|----------|-------------------|-----|------|-------------|--------------------|----------------|-----------------------------------------------------------------------------|-------|
| NOTE: |     | REFERENCE DRAWINGS                                                                                             |     | REVISIONS |          |                   |     |      |             | ENGINEERING RECORD |                | <div>CLIENT LOGO</div>                                                      |       |
|       | NO. | TITLE                                                                                                          | NO. | FIRM      | DATE     | DESCRIPTION       | BY  | CHK. | APP.        | BY                 | DATE           |                                                                             |       |
|       | -   | -                                                                                                              | A   | MSC       | 09/25/21 | ISSUED FOR REVIEW | GJR | -    | -           | DRN: GJR           | 09/25/21       | <div>SPACEX LAUNCH TANK FARM<br/>LAUNCH FACILITIES – UTILITY SERVICES</div> |       |
|       |     |                                                                                                                | B   |           |          |                   |     |      |             | DES: -             | -              |                                                                             |       |
|       |     |                                                                                                                | C   |           |          |                   |     |      |             | CHK: -             | -              |                                                                             |       |
|       |     |                                                                                                                | D   |           |          |                   |     |      |             | APP: -             | -              |                                                                             |       |
|       | MSC | MARS SPACE CONSTRUCTION, LLC<br>ENGINEERING, DESIGN & CONSTRUCTION<br>TEXAS REGISTERED ENGINEERING FIRM F-XXXX | E   |           |          |                   |     |      |             | AFE No. -          | -              | <div>PROCESS FLOW DIAGRAM<br/>BOCA CHICA, TEXAS</div>                       |       |
|       |     |                                                                                                                | F   |           |          |                   |     |      |             | SE&C JOB NO. -     | -              |                                                                             |       |
|       |     |                                                                                                                |     |           |          |                   |     |      |             | PROJ. ENGR: -      | -              |                                                                             |       |
|       |     |                                                                                                                |     |           |          |                   |     | XXXX | SCALE: NONE | N/A                | PLOT SCALE N/A | DWG. NO. D-XXXX-P00-102                                                     | REV A |